


RoHS Compliant


A 2\*DVI (24+5)P FEMALE DVI (24+5)P MALE

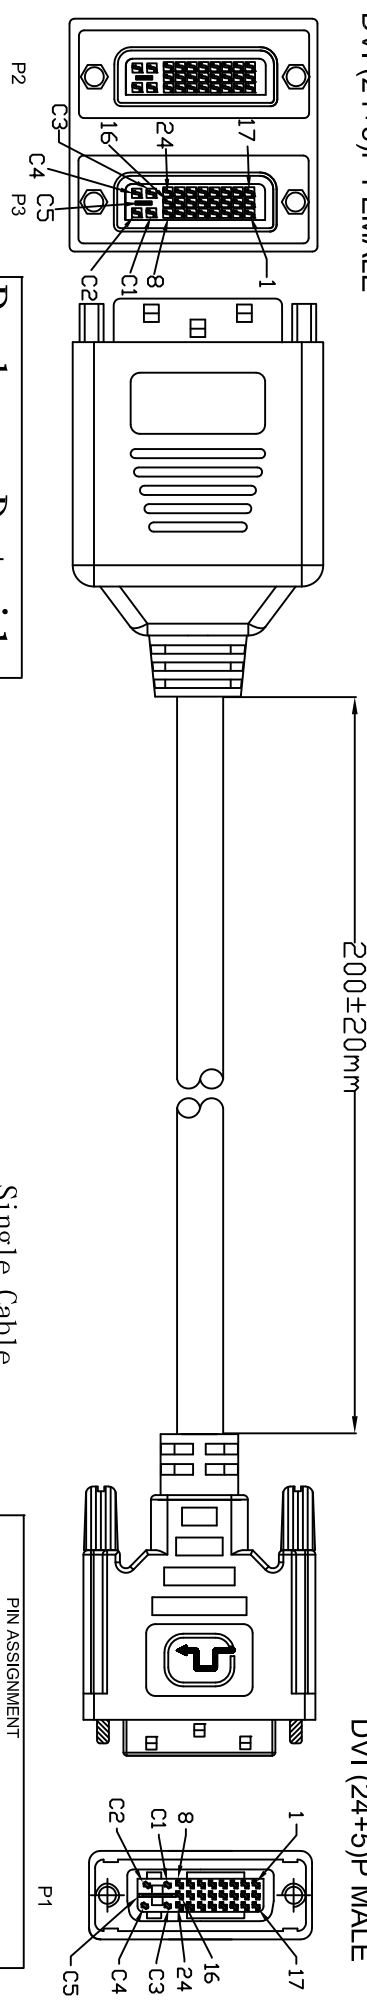

**Package Details**

P/N	Cable Length	Rolling Size (Single Cable)	Polybag Type (Single Cable)	Bag Size (Single Cable)	Article Weight (Single Cable)
AK-320401-002-S	0.2m	N/A	Ordinary Polybag (Heat Sealed)	190*160*0.05mm	0.135kg


**Single Cable**

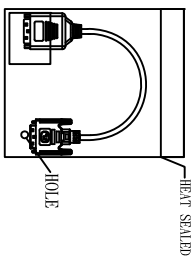

**Inner Packing Unit**

P/N	Cable Length	Quantity (Inner Packing Unit)	Type Polybag (Heat Sealed)	Size (Inner Packing Unit)	Weight (Inner Packing Unit)
AK-320401-002-S	0.2m	10 pcs		450*350*0.05mm	1.350kg

**Inner Packing Unit**

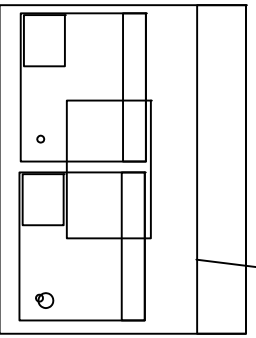


**PIN ASSIGNMENT**

Pin	Signal	Pin	Signal
P1	RED VIDEO	P2	C1
C1	GREEN VIDEO	C2	GREEN VIDEO
C2	BLUE VIDEO	C3	BLUE VIDEO
C3	ANALOG HORIZ SYNC	C4	ANALOG HORIZ SYNC
C4	RED GND	C5	RED GND
C5	GREEN GND		
	BLUE GND		
1	TMDS DATA 2-	17	TMDS DATA 0-
2	TMDS DATA 2+	18	TMDS DATA 0+
3	TMDS DATA 2# SHIELD	19	TMDS DATA 0# SHIELD
4	TMDS DATA 4-	20	TMDS DATA 5-
5	TMDS DATA 4+	21	TMDS DATA 5+
9	TMDS DATA 1-	23	TMDS CLOCK+
10	TMDS DATA 1+	24	TMDS CLOCK-
11	TMDS DATA 3-	22	TMDS CLOCK SHIELD
12	TMDS DATA 3+		
13	TMDS DATA 1# SHIELD		
14	TMDS DATA 3# SHIELD		
15	TMDS DATA 1# SHIELD		
16	TMDS DATA 3# SHIELD		
17	TMDS DATA 0-		
18	TMDS DATA 0+		
19	TMDS DATA 0# SHIELD		
20	TMDS DATA 5-		
21	TMDS DATA 5+		
22	TMDS CLOCK+		
23	TMDS CLOCK-		
24	TMDS CLOCK SHIELD		
6	DDC CLOCK	6	GND
7	DDC DATA	7	POWER 5V
8	ANALOG VERT. SYNC	8	HOT PLUG DETECT
15	GND		
16	POWER 5V		
17	HOT PLUG DETECT		
Shield	Shield	Shield	Shield

**CARTON DETAILS**

P/N	Cable Length	Quantity (Carton)	Measurement (Carton)	N.W. (Carton)	G.W. (Carton)
AK-320401-002-S	0.2m	100pcs	45*32*25cm	13.5kg	14.5kg

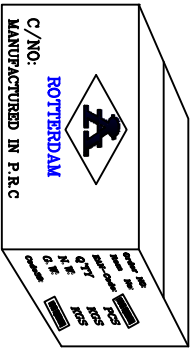

\*"ROTTERDAM" is for Sea Freight shipment  
 \*\*"COLOGNE" is for Air Freight shipment  
 \*"LUDENSCHIED" is for Fedex or UPS shipment

Drawn by	Date	Name	Libra
Checked by	June30,2011		
Approved by			

**ASSMANN**  
 Electronic GmbH

Part No. **AK-320401-002-S**  
 EAN:4016032298571

DVI (24+5)P/M - DVI (24+5)P/F + HD8 15P/F CABLE

Title	Scale	N/A	Sheet
Unit	MM		1/2

STxxxxx